


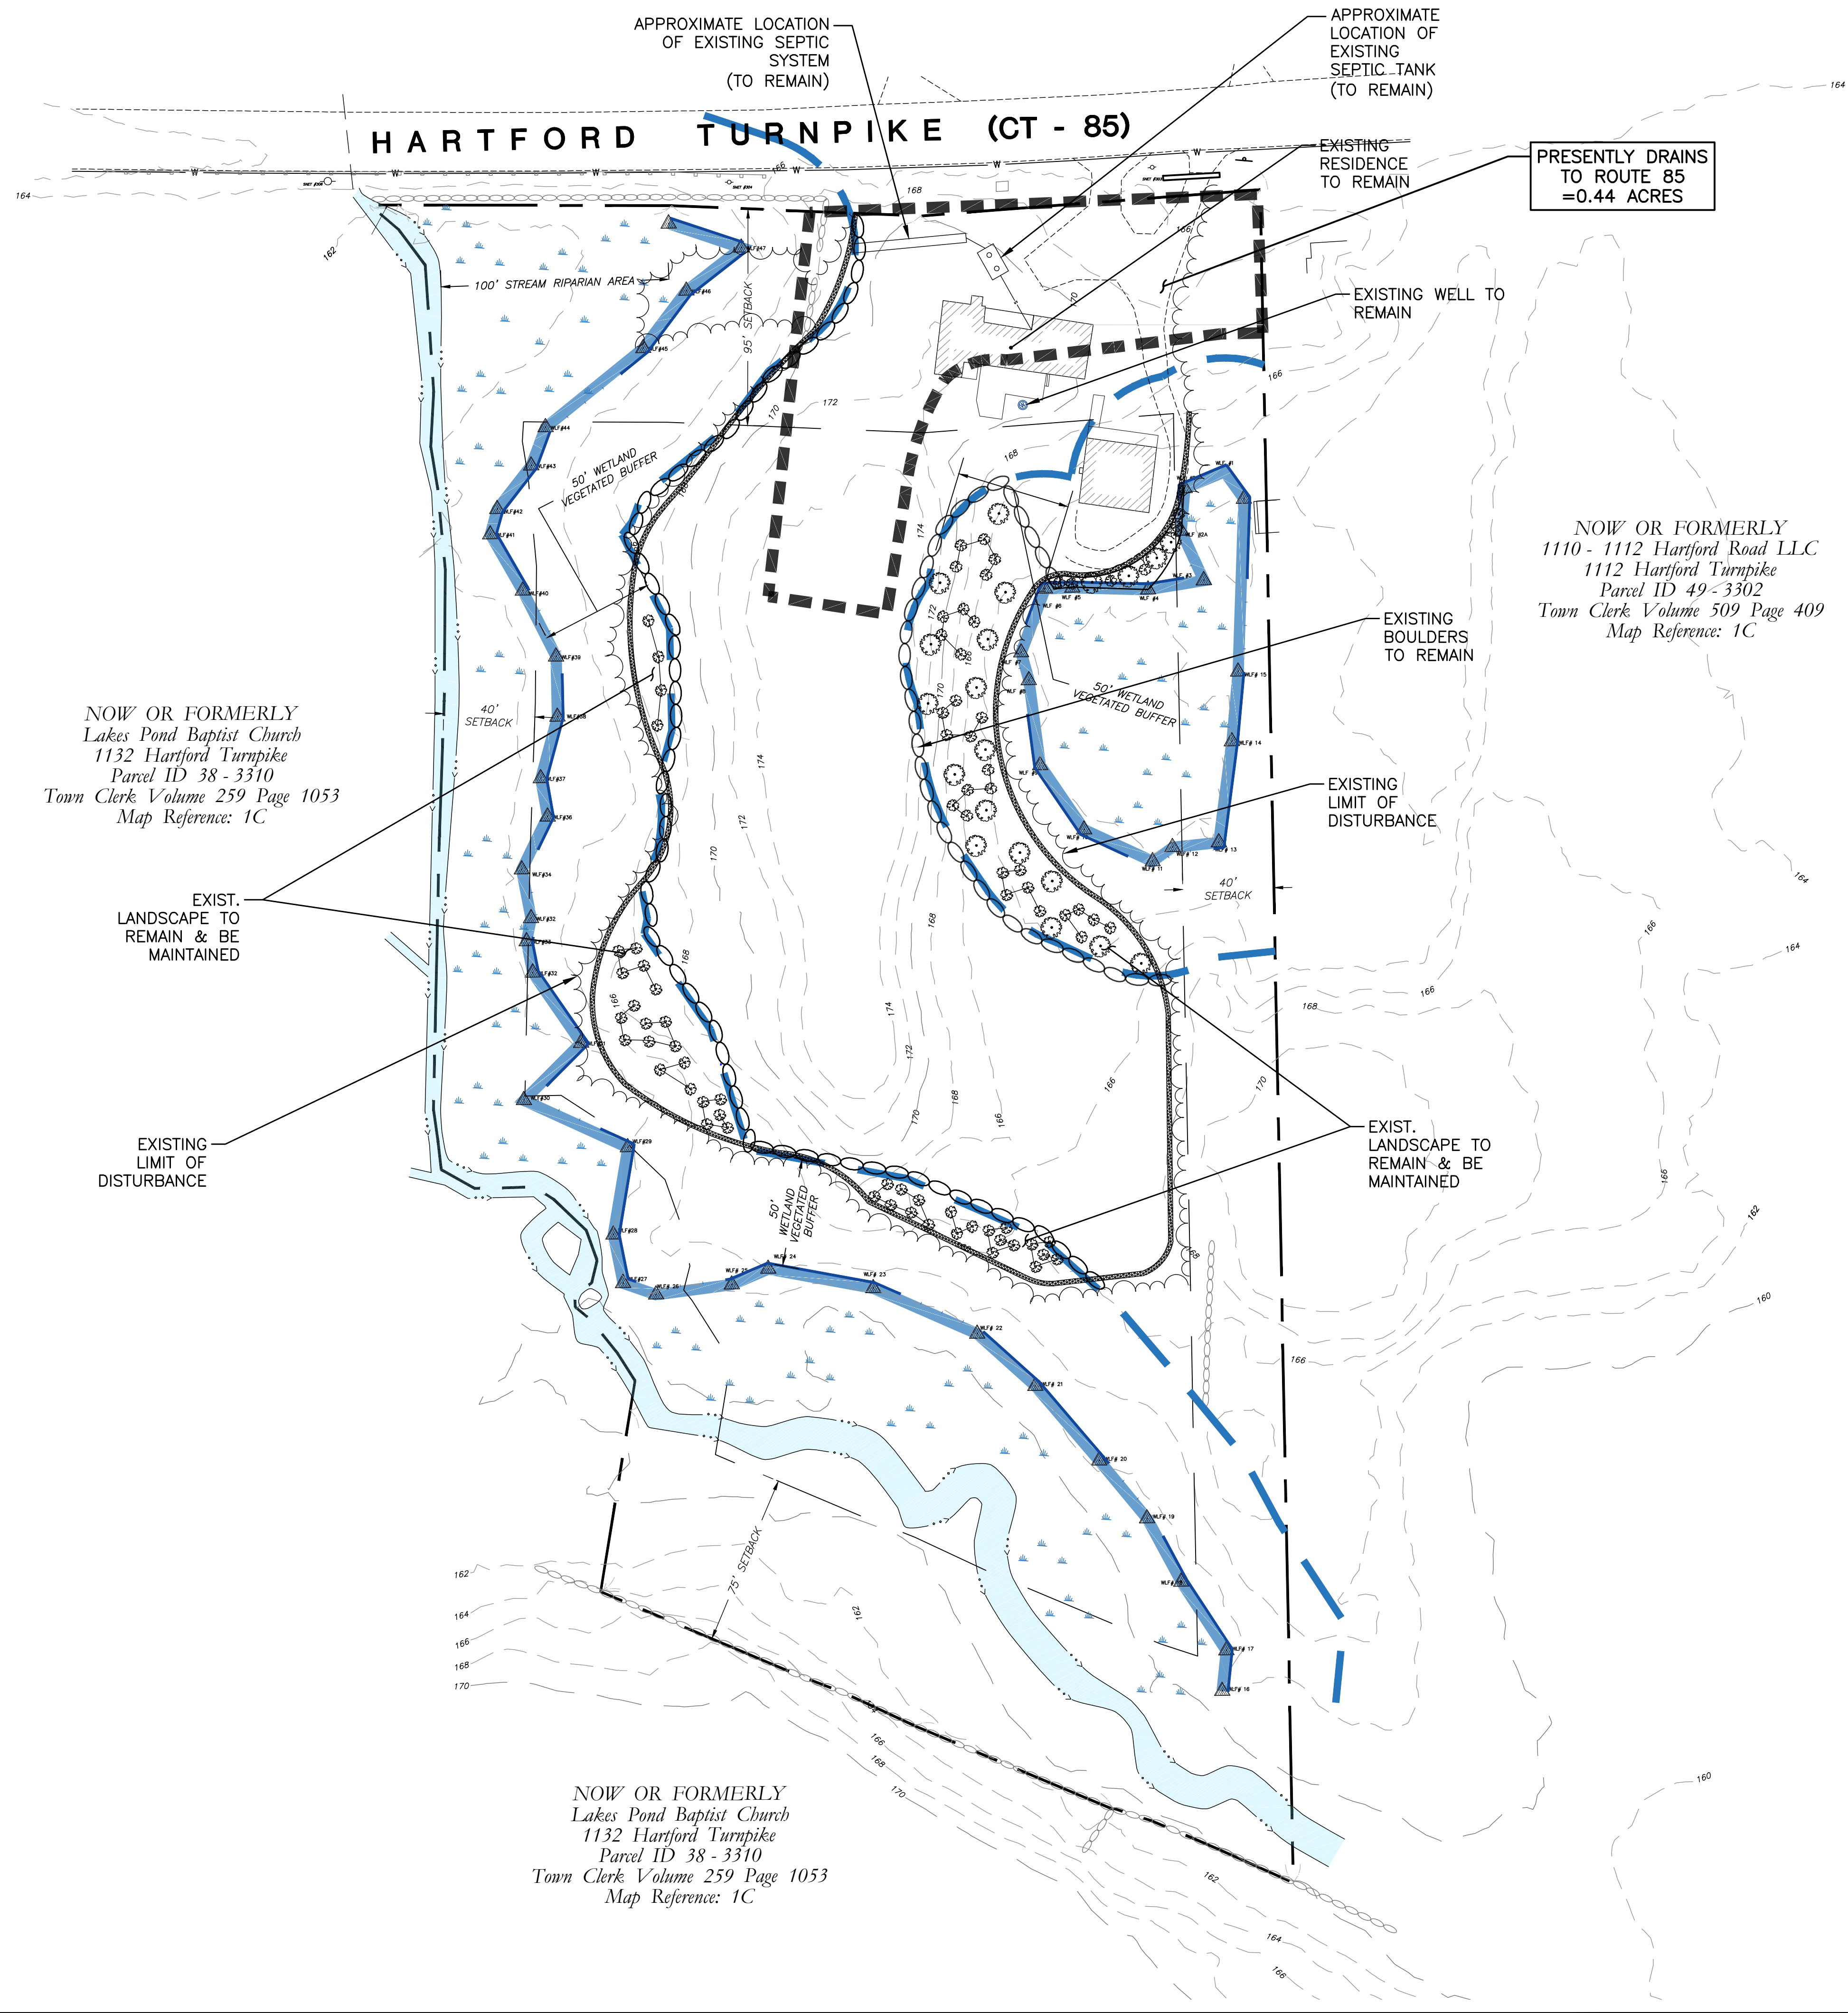

				CLA Engineers, Inc. CIVIL • STRUCTURAL • SURVEYING 317 Main Street Norwich, CT 06360 (860) 886-1966 Fax (860) 886-9165
No.	DATE	REVISION		
		1122 & 1124 HARTFORD TURNPIKE		Project No. CLA-7226
		EAST LYME TREE SERVICES		Proj. Engineer E.M.B.
				Date: 4/19/23
		EXISTING DRAINAGE PLAN		Sheet No. 1