


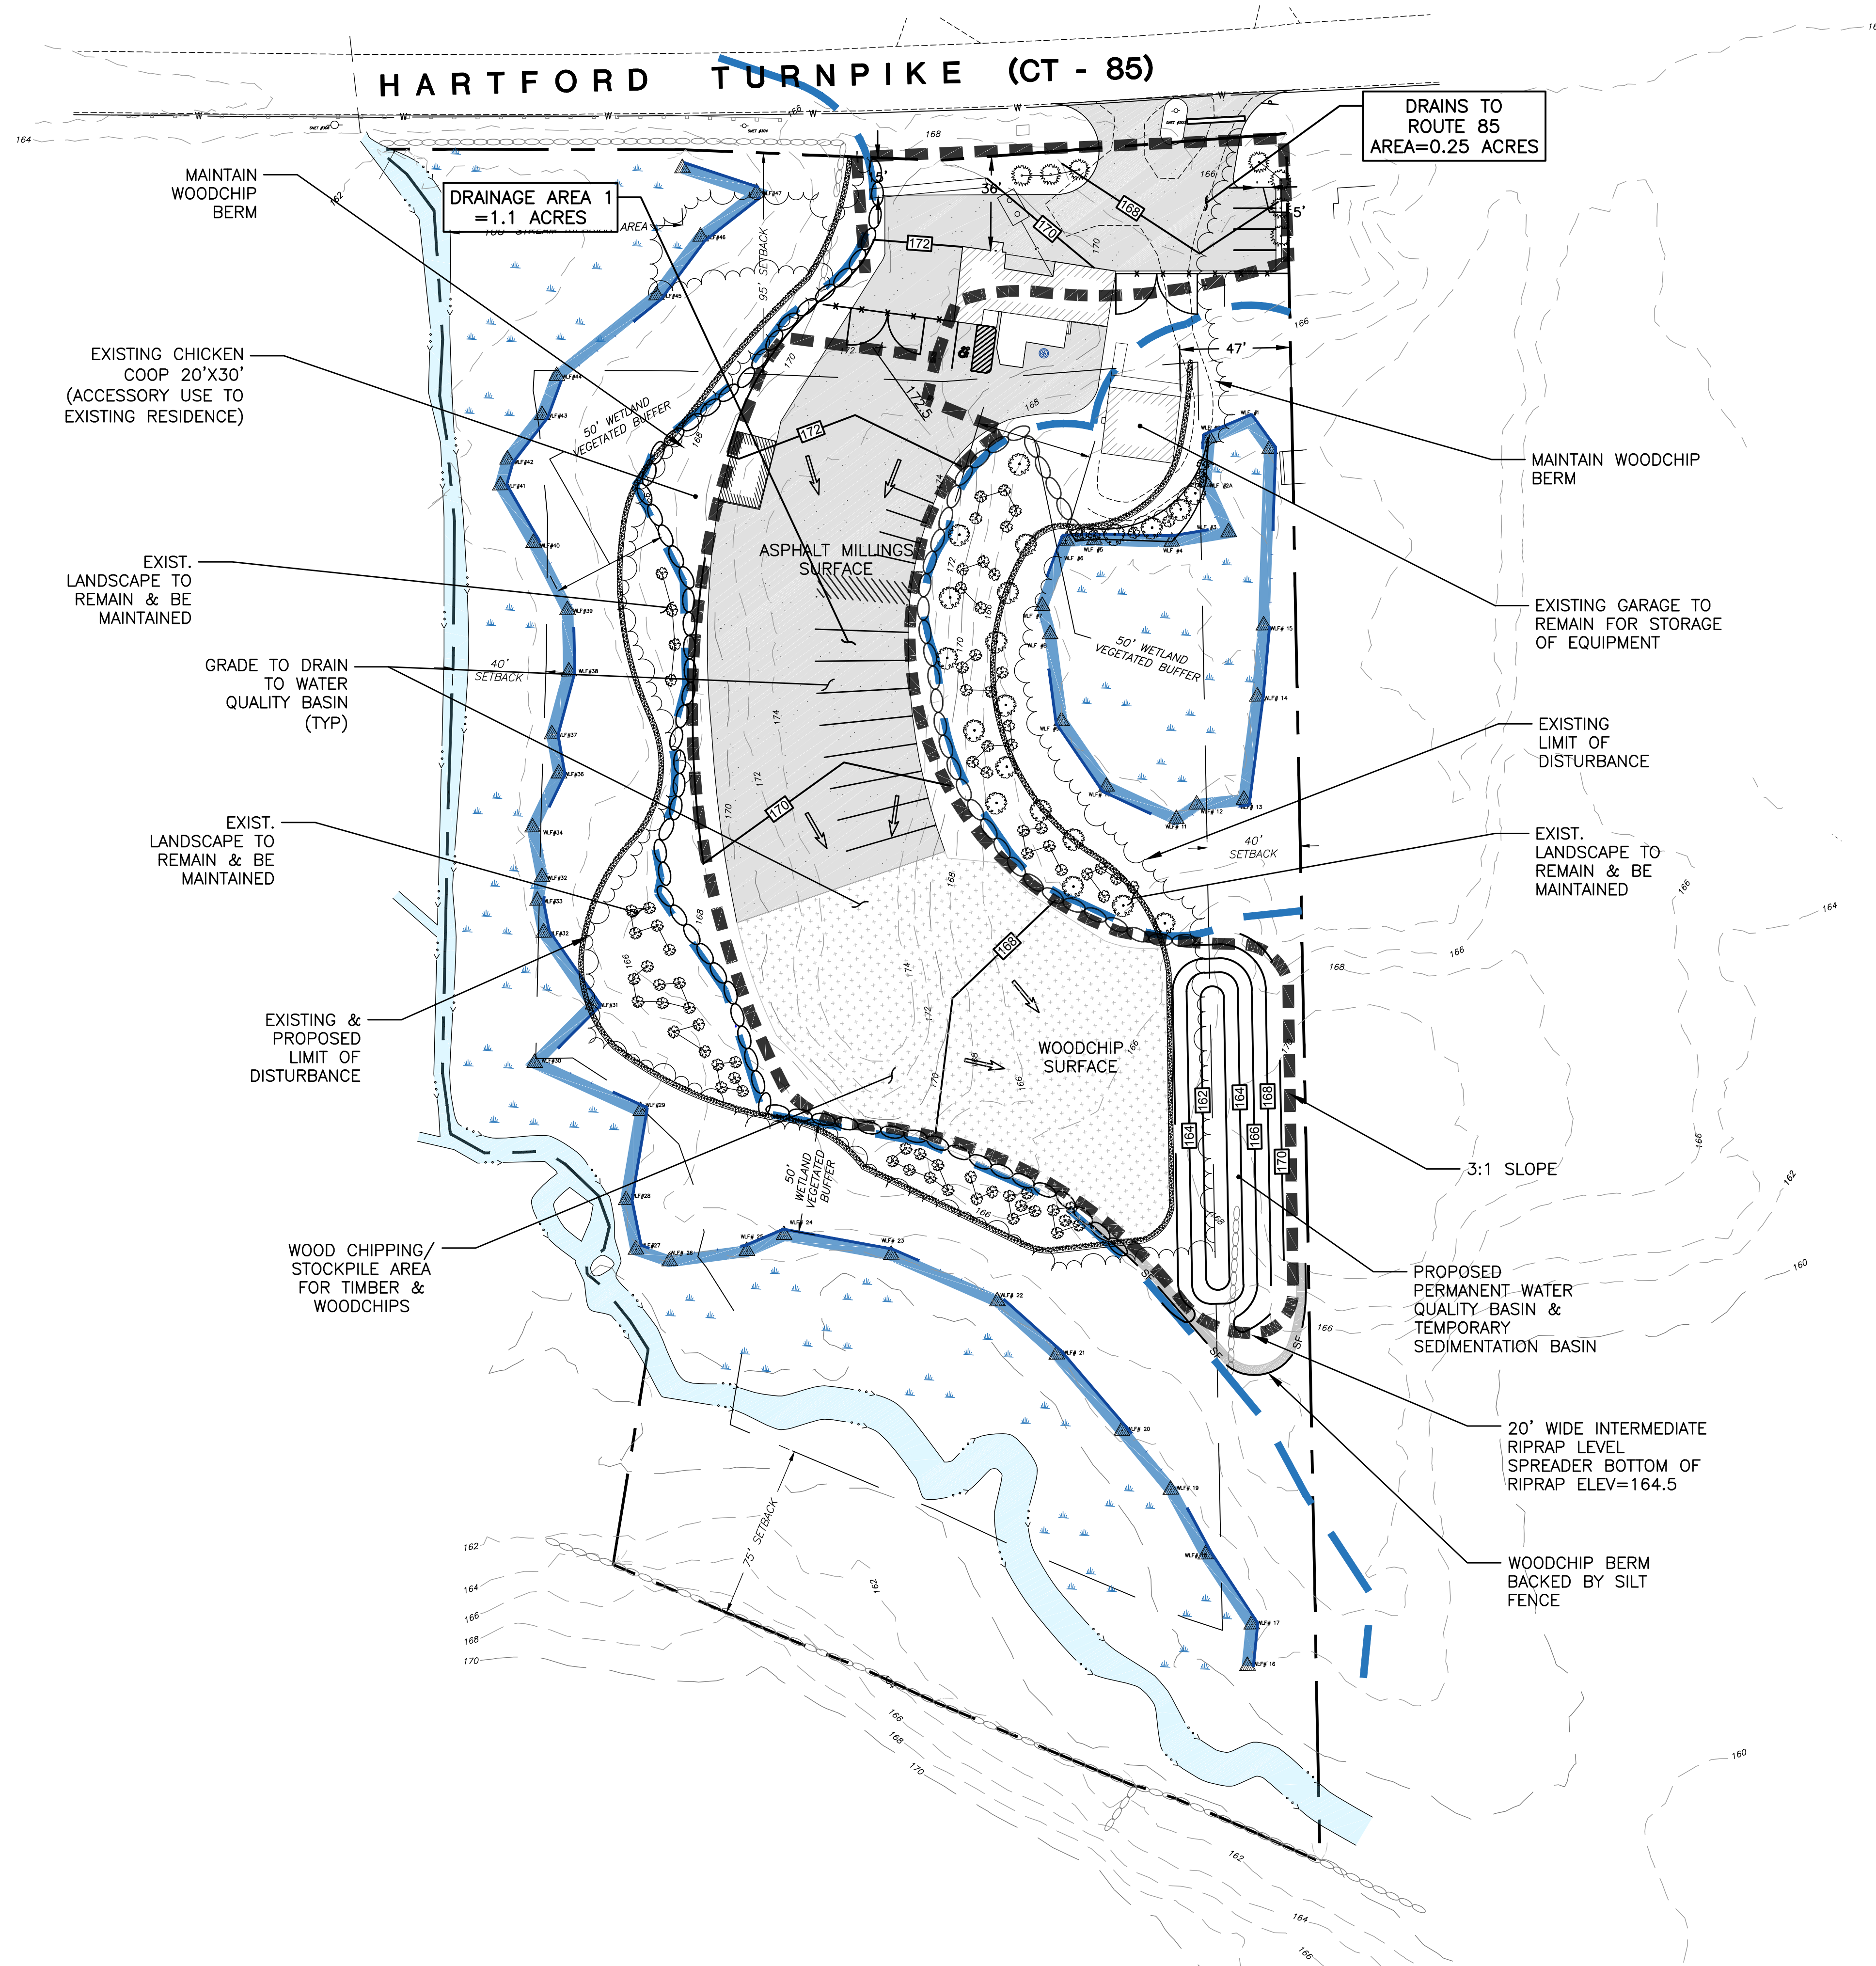

40' 0 40' 80'
SCALE: 1"=40'

			CLA Engineers, Inc. Civil • Structural • Surveying	
			317 Main Street Norwich, CT 06360 (860) 886-1986 Fax (860) 886-9165	
No.	DATE	REVISION		
			1122 & 1124 HARTFORD TURNPIKE	
			EAST LYME TREE SERVICES	
			PROPOSED DRAINAGE PLAN	
			Project No. CLA-7228	
			Proj. Engineer E.M.B.	
			Date: 4/19/23	
			Sheet No.	2