


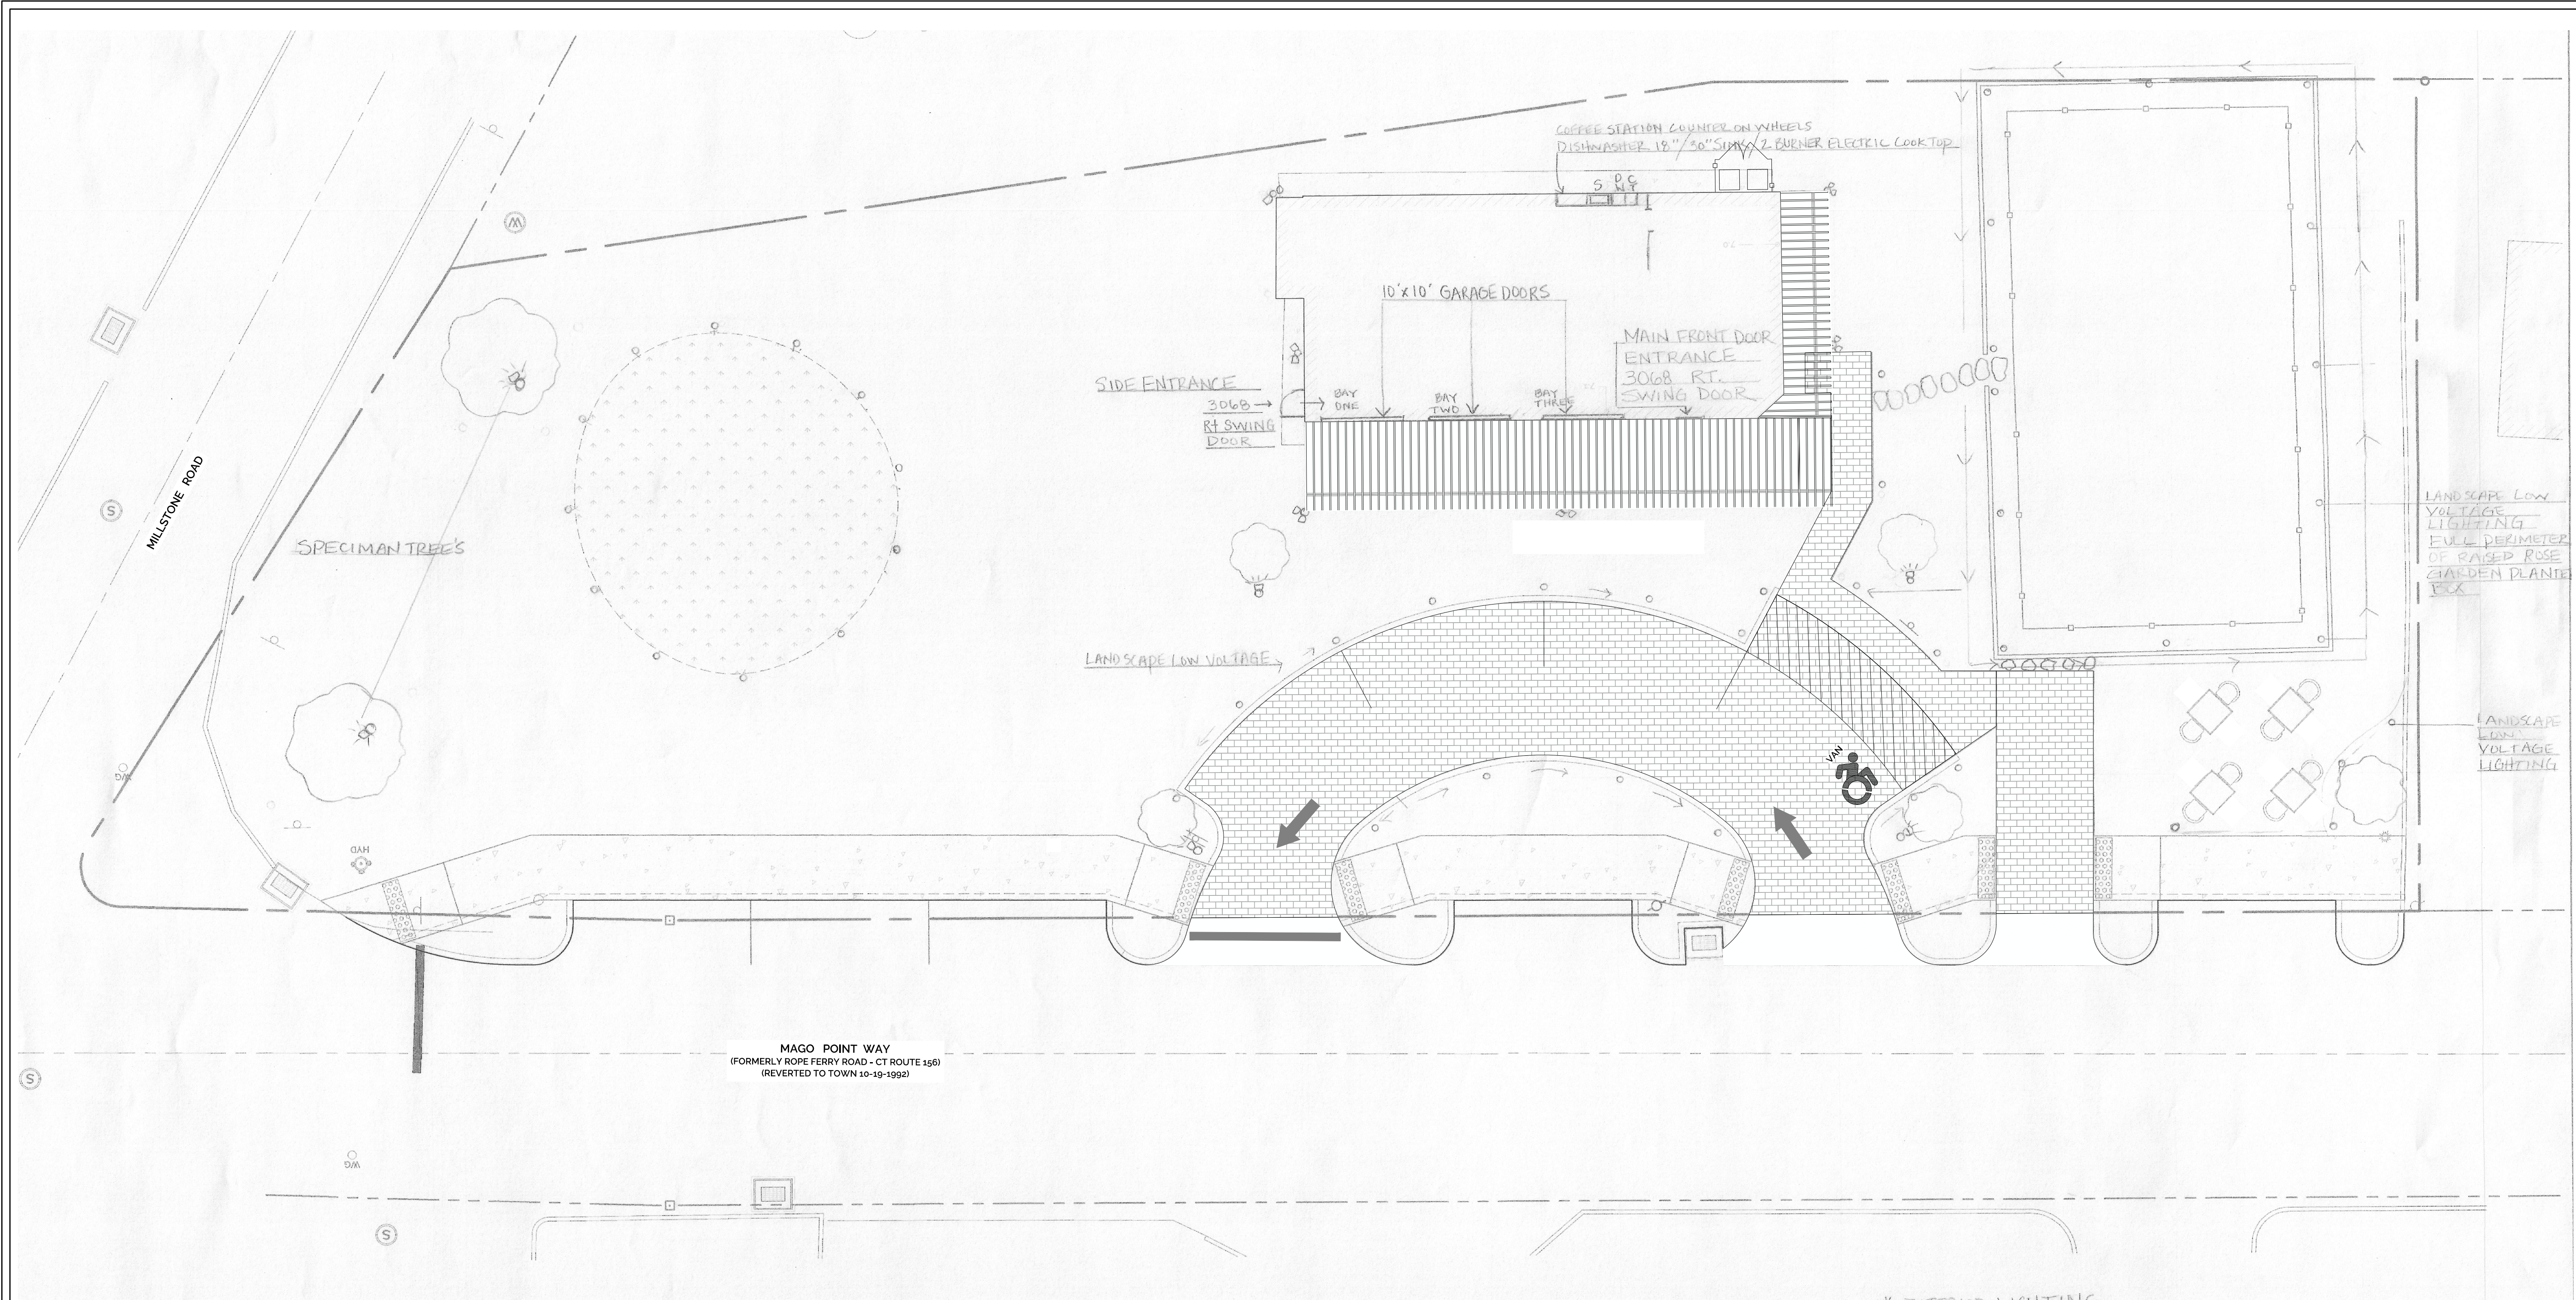

- * EXTERIOR LIGHTING**
- 8" DOUBLE SPOT LIGHT
 - 8" SINGLE SPOT - UNDER PERGOLA FOR TABLE LIGHTING
 - 8" LOW VOLTAGE LIGHTING - HANDICAP/DRIVEWAY/WALKWAY/ AND LANDSCAPE AREAS
 - 8" LOW VOLTAGE SINGLE GROUND TREE SPOTLIGHT
- * DOORS**
- 3068 SIDE ENTRANCE & MAIN FRONT DOOR ENTRANCE
 - GARAGE BAY DOORS
 - SIGNAGE LOCATION CENTER PERGOLA
- * COFFEE/KITCHEN COUNTER ON WHEELS**
DISHWASHER 18" / SINK 30" / COOKTOP CT 24"

H+H+H
ENGINEERING
ASSOCIATES

232 Greenmanville Avenue
Suite 201
Mystic, CT 06355
860-980-8008 (O) 413-579-4488 (M)
www.hh-engineers.com

STAMP

DATE	APPR.	SMM
4/6/2023		

REV	DESCRIPTION OF REVISION
1	REVISIONS PER TOWN REVIEW COMMENTS

LIGHTING PLAN

NEW PICKLEBALL COURT AND CLUBHOUSE
PROPERTY ADDRESS
358 & 360 MAGO POINT WAY, WATERFORD, CT 06385
PREPARED FOR
MAGO WAY REALTY LLC
16 POWDER HORN HILL ROAD, WILTON, CT 06897

10 5 0 5 10
SCALE IN FEET

PROJECT NO.
2022-0037
SCALE
1" = 10'

DRAWN BY:
SMM
DATE
2/20/2023

CHECKED BY:
SMM
DATE
2/20/2023

DRAWING
LT-1

SHEET NUMBER: 4 OF 5

2: SHARED H+H ENGINEERING ASSOCIATES PROJECTS 10222-0037-0037 - DAYBESK - 358 MAGO POINT RD. WATERFORD LOWES SITE PLAN - 358 MAGO POINT WAY/DWG 100 LIGHTING Saved: 2/20/2023 12:57 PM Filesize: 4.70/2023 103 KB