


M:\000\7401\295 & 313 Willets Ave Drawings\7401 - 295 & 313 Willets Ave Drainage Plans.V5.dwg, 8/10/2023 1:56:16 PM, DWG To PDF.pc3



CLA

			CLA Engineers, Inc. CIVIL • STRUCTURAL • SURVEYING	
			317 Main Street Norwich, CT 06360 (860) 886-1966 Fax (860) 886-9165	
No.	DATE	REVISION		
			WATERFORD, CT	Project No. CLA-7401
			295 & 313 WILLETTTS AVENUE	Proj. Engineer E.M.B.
				Date: 1/17/23
				Sheet No. 1
			EXISTING DRAINAGE CONDITIONS	

M:\0000\400\7401 295 & 313 Willetts Ave Drawings\7401 - 295 & 313 Willetts Ave Drainage Plans V5.dwg, 8/10/2023 2:03:57 PM, DWG To PDF.pc3

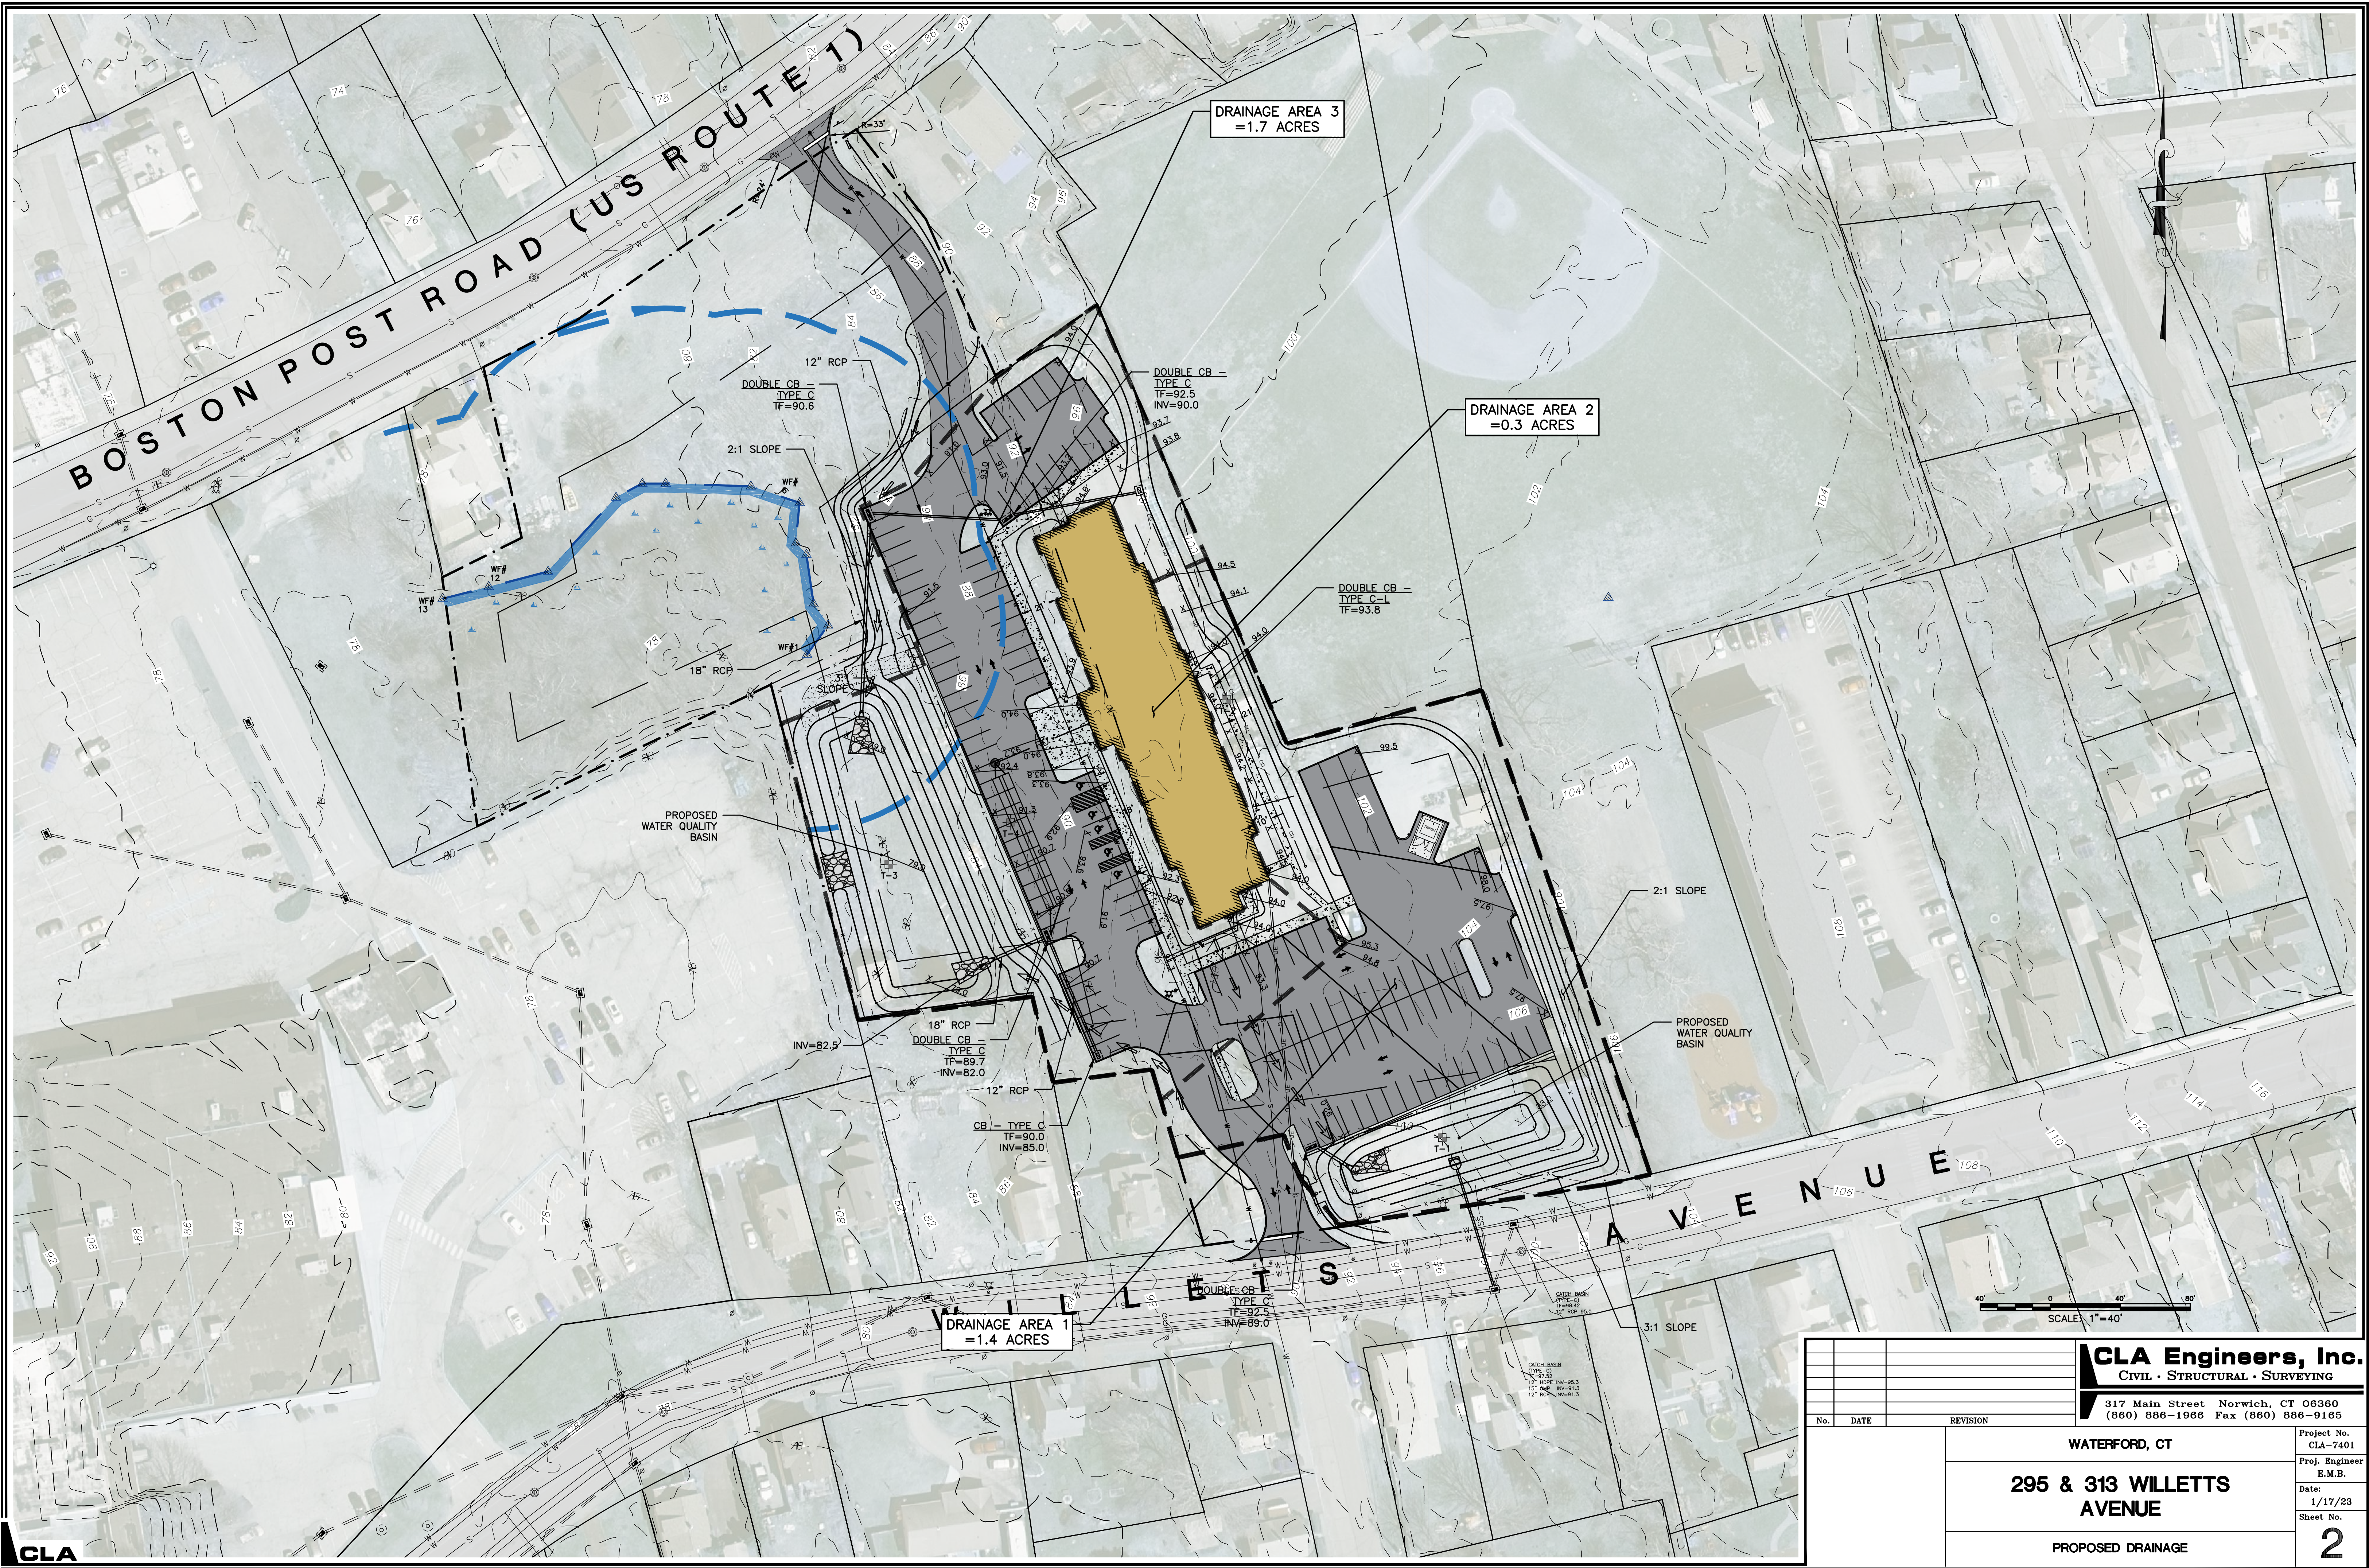

CLA

			CLA Engineers, Inc. CIVIL • STRUCTURAL • SURVEYING	
			317 Main Street Norwich, CT 06360 (860) 886-1966 Fax (860) 886-9165	
			Project No. CLA-7401	Proj. Engineer E.M.B.
			Date: 1/17/23	Sheet No. 2
			WATERFORD, CT	
			295 & 313 WILLETT'S AVENUE	
			PROPOSED DRAINAGE	
No.	DATE	REVISION		